

REVISED LAYOUT PLAN OF IIBF CENTRE AT GUWAHATI

CLIENT

INDIAN INSTITUTE OF BANKING FINANCE

Tower-1 , Commercial –II ,
Kohinoor City , Kurla West
Mumbai – 400 070,
Maharashtra, India.



Description of Proposal.


**REVISED LAYOUT PLAN OF IIBF TRAINING CENTRE
AT PANBAZAR, GUWAHATI, ASSAM**

THIRD FLOOR PLAN

FLOOR PLAN

JOB NO.	DATE	SCALE	DEALT BY	CHKD BY	DRG NO.
			AR. DEBOJYOTI DEBROY		

SIGN & STAMP

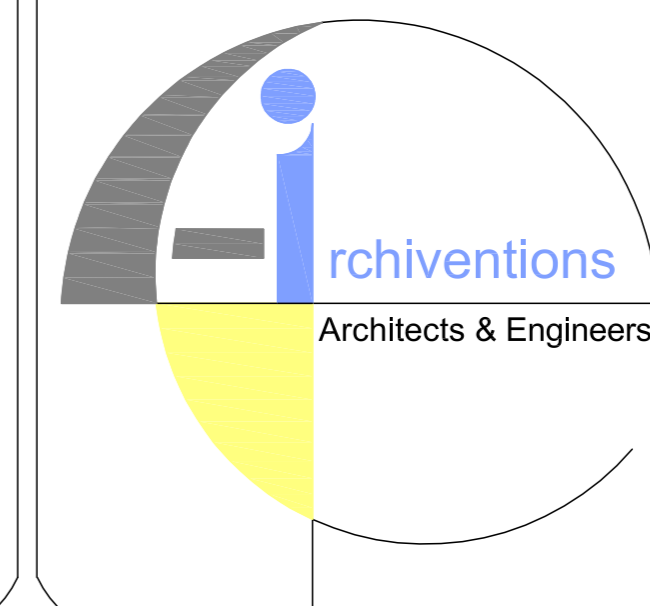

FIRM NAME & ADDRESS

ARCHIVENTIONS

Architects , Planners & Interior Designers
C.O.A. Regd. No.- CA / 2004 / 32922

ADDRESS

HOUSE NO- 95, GROUND FLOOR
LACHITNAGAR MAIN ROAD,
LACHITNAGAR, GUWAHATI-781007, ASSAM
PH-+91-9854062928/ 9436017122




---ROAD---

FALSE CEILING LAYOUT PLAN OF IIBF CENTRE AT GUWAHATI

-  24" x 24" PANEL LIGHT
-  12" x 12" PANEL LIGHT
-  15 / 12 W DOWNLIGHT AS EMERGENCY LIGHT
-  15 / 18 W DOWNLIGHT
-  STRIP/ ROBE LIGHT

CLIENT
INDIAN INSTITUTE OF BANKING FINANCE
 Tower-1 , Commercial -II , Kohinoor City , Kurla West
 Mumbai - 400 070, Maharashtra, India.




Description of Proposal.
FALSE CEILING LAYOUT PLAN OF IIBF CENTRE AT GUWAHATI

THIRD FLOOR PLAN

FLOOR PLAN

JOB NO.	DATE	SCALE	DEALT BY	CHKD BY	DRG NO.
			AR. DEBOJYOTI DEBROY		

SIGN & STAMP

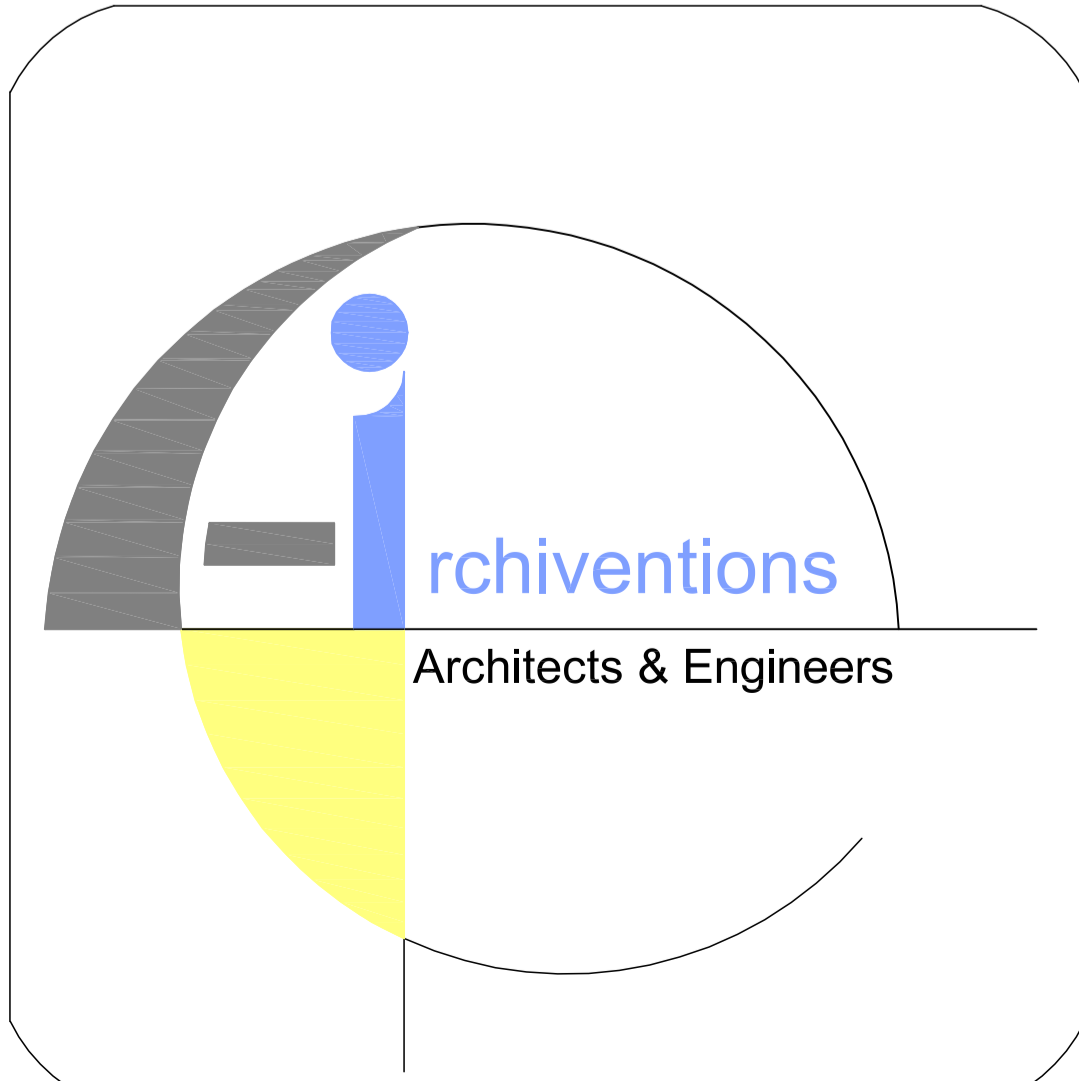


FIRM NAME & ADDRESS


ARCHIVENTIONS
 Architects , Planners & Interior Designers
 C.O.A. Regd. No.- CA / 2004 / 32922


ADDRESS
 HOUSE NO- 95, GROUND FLOOR
 LACHITNAGAR MAIN ROAD,
 LACHITNAGAR, GUWAHATI-781007, ASSAM
 PH-+91-9854062928/ 9436017122

Symbol	Description	Qty
	LED Round Down light Fixture 1x18 W	58
	2ft x 2ft LED Panel light 1x30W	38
	LED tube light 1200mm 20W	38
	Emergency Light 14W	20
	LED tube Light 600mm 14W	
	Wall Fan 1x60W	21
	6A Socket 1x200 W on Row Power	18
	6A Socket 1x100W on Common Switch Board	3
	3X(G/16A) UPS Socket 1x500W	12
	20A AC Socket 1x2000W	12
	LAN ports	18
	Telephone	2
	Switch Board	23
	Light Distribution Board	1
	Power distribution Board	1
	UPS Distribution board	1
	Main Switch	0
	Wall Mounted Main Panel	1

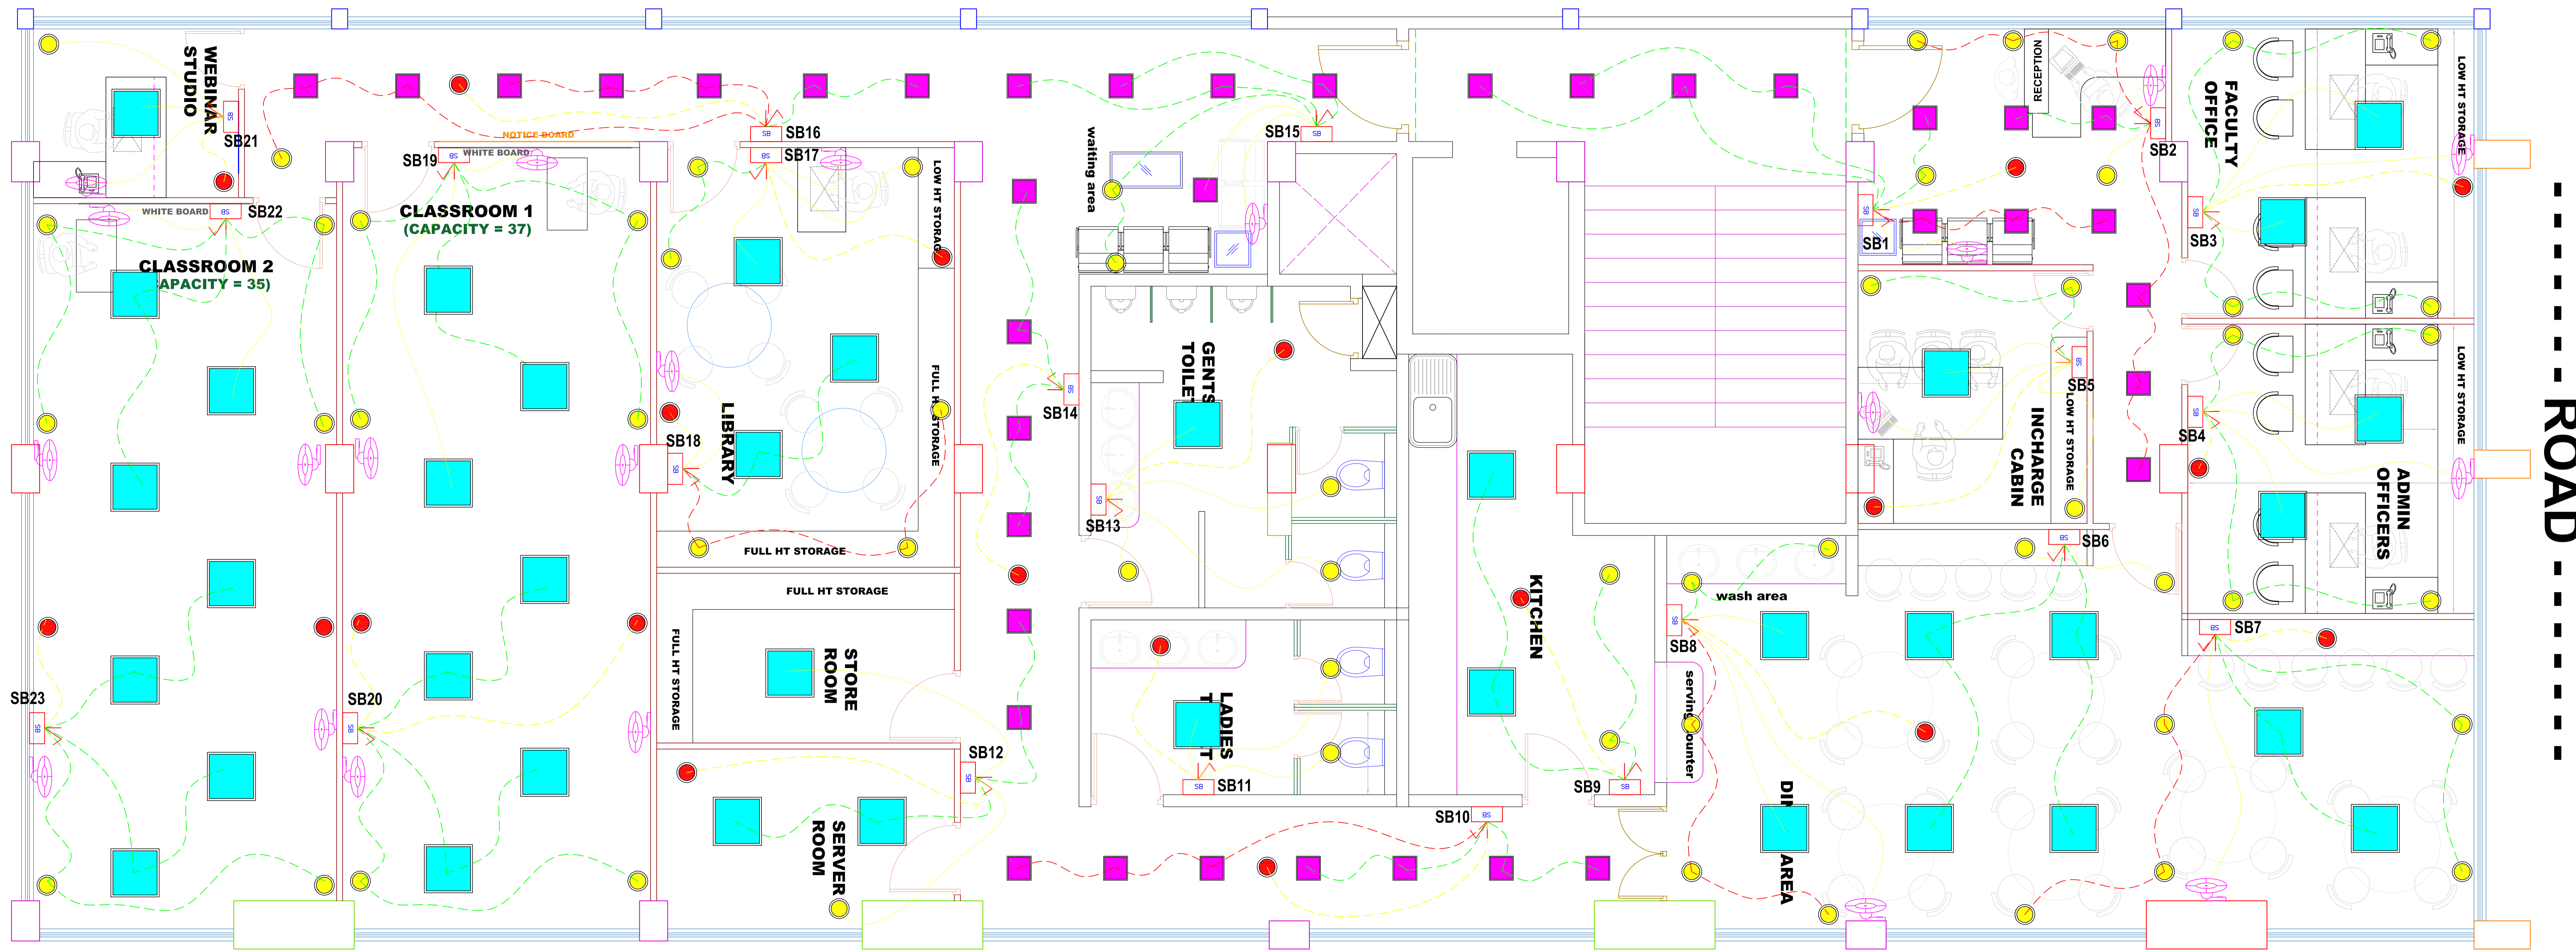


CIRCUIT DIAGRAM OF IIBF CENTRE AT PANBAZAR, GUWAHATI

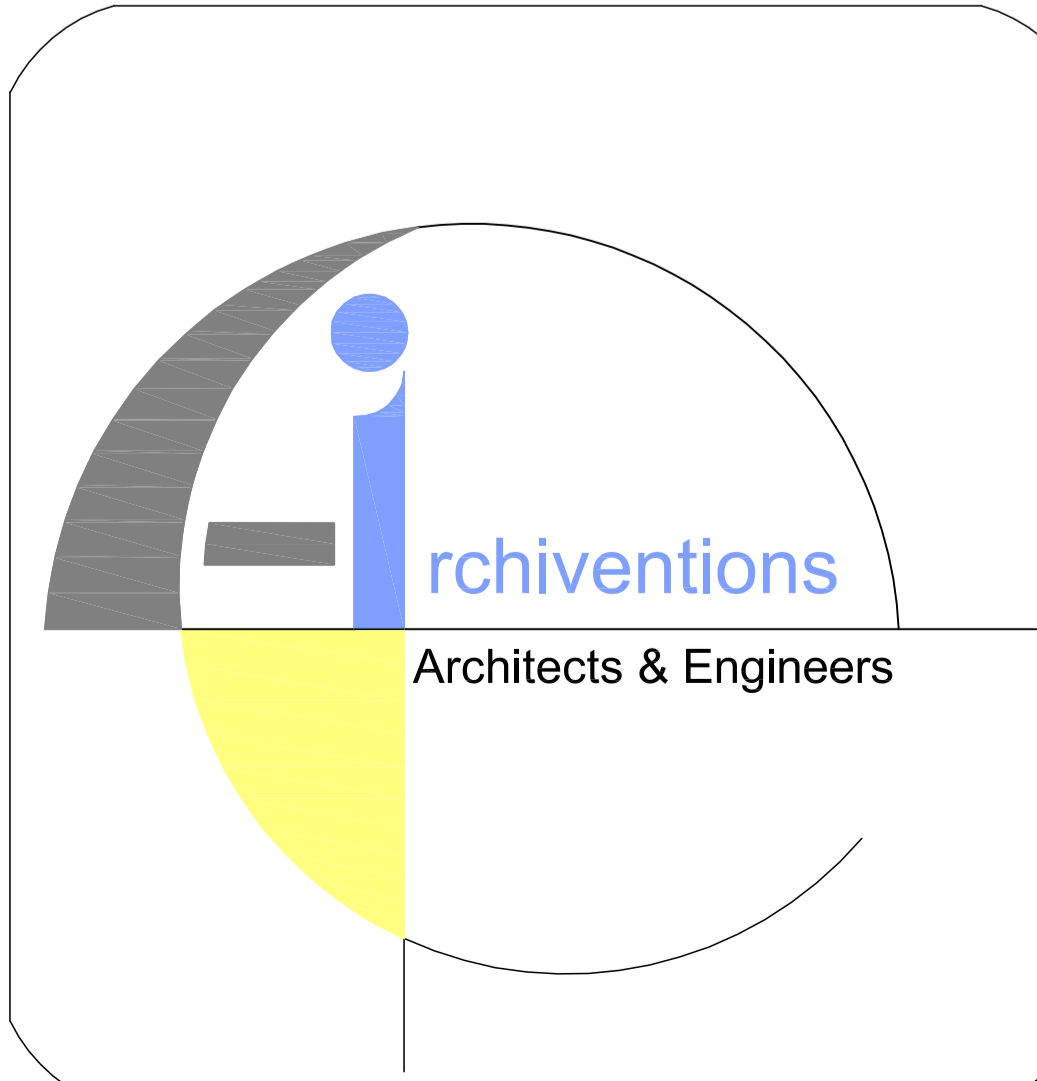
CLIENT INDIAN INSTITUTE OF BANKING FINANCE Tower-1 , Commercial -II , Kohinoor City, Kuria West Mumbai – 400 070, Maharashtra, India.	Description of Proposal. APPROVED LAYOUT PLAN OF IIBF CENTRE AT PANBAZAR, GUWAHATI					SIGN & STAMP 	FIRM NAME & ADDRESS ARCHIVENTIONS Architects , Planners & Interior Designers C.O.A. Regd. No.- CA / 2004 / 32922 ADDRESS HOUSE NO- 95, GROUND FLOOR LACHITNAGAR MAIN ROAD, LACHITNAGAR, GUWAHATI-781007, ASSAM PH-+91-9854062928/ 9436017122
	FLOOR PLAN	THIRD FLOOR PLAN					
	JOB NO.	DATE	SCALE	DEALT BY	DRG NO.		
				AR. DEBOJYOTI DEBROY	CHKD BY		

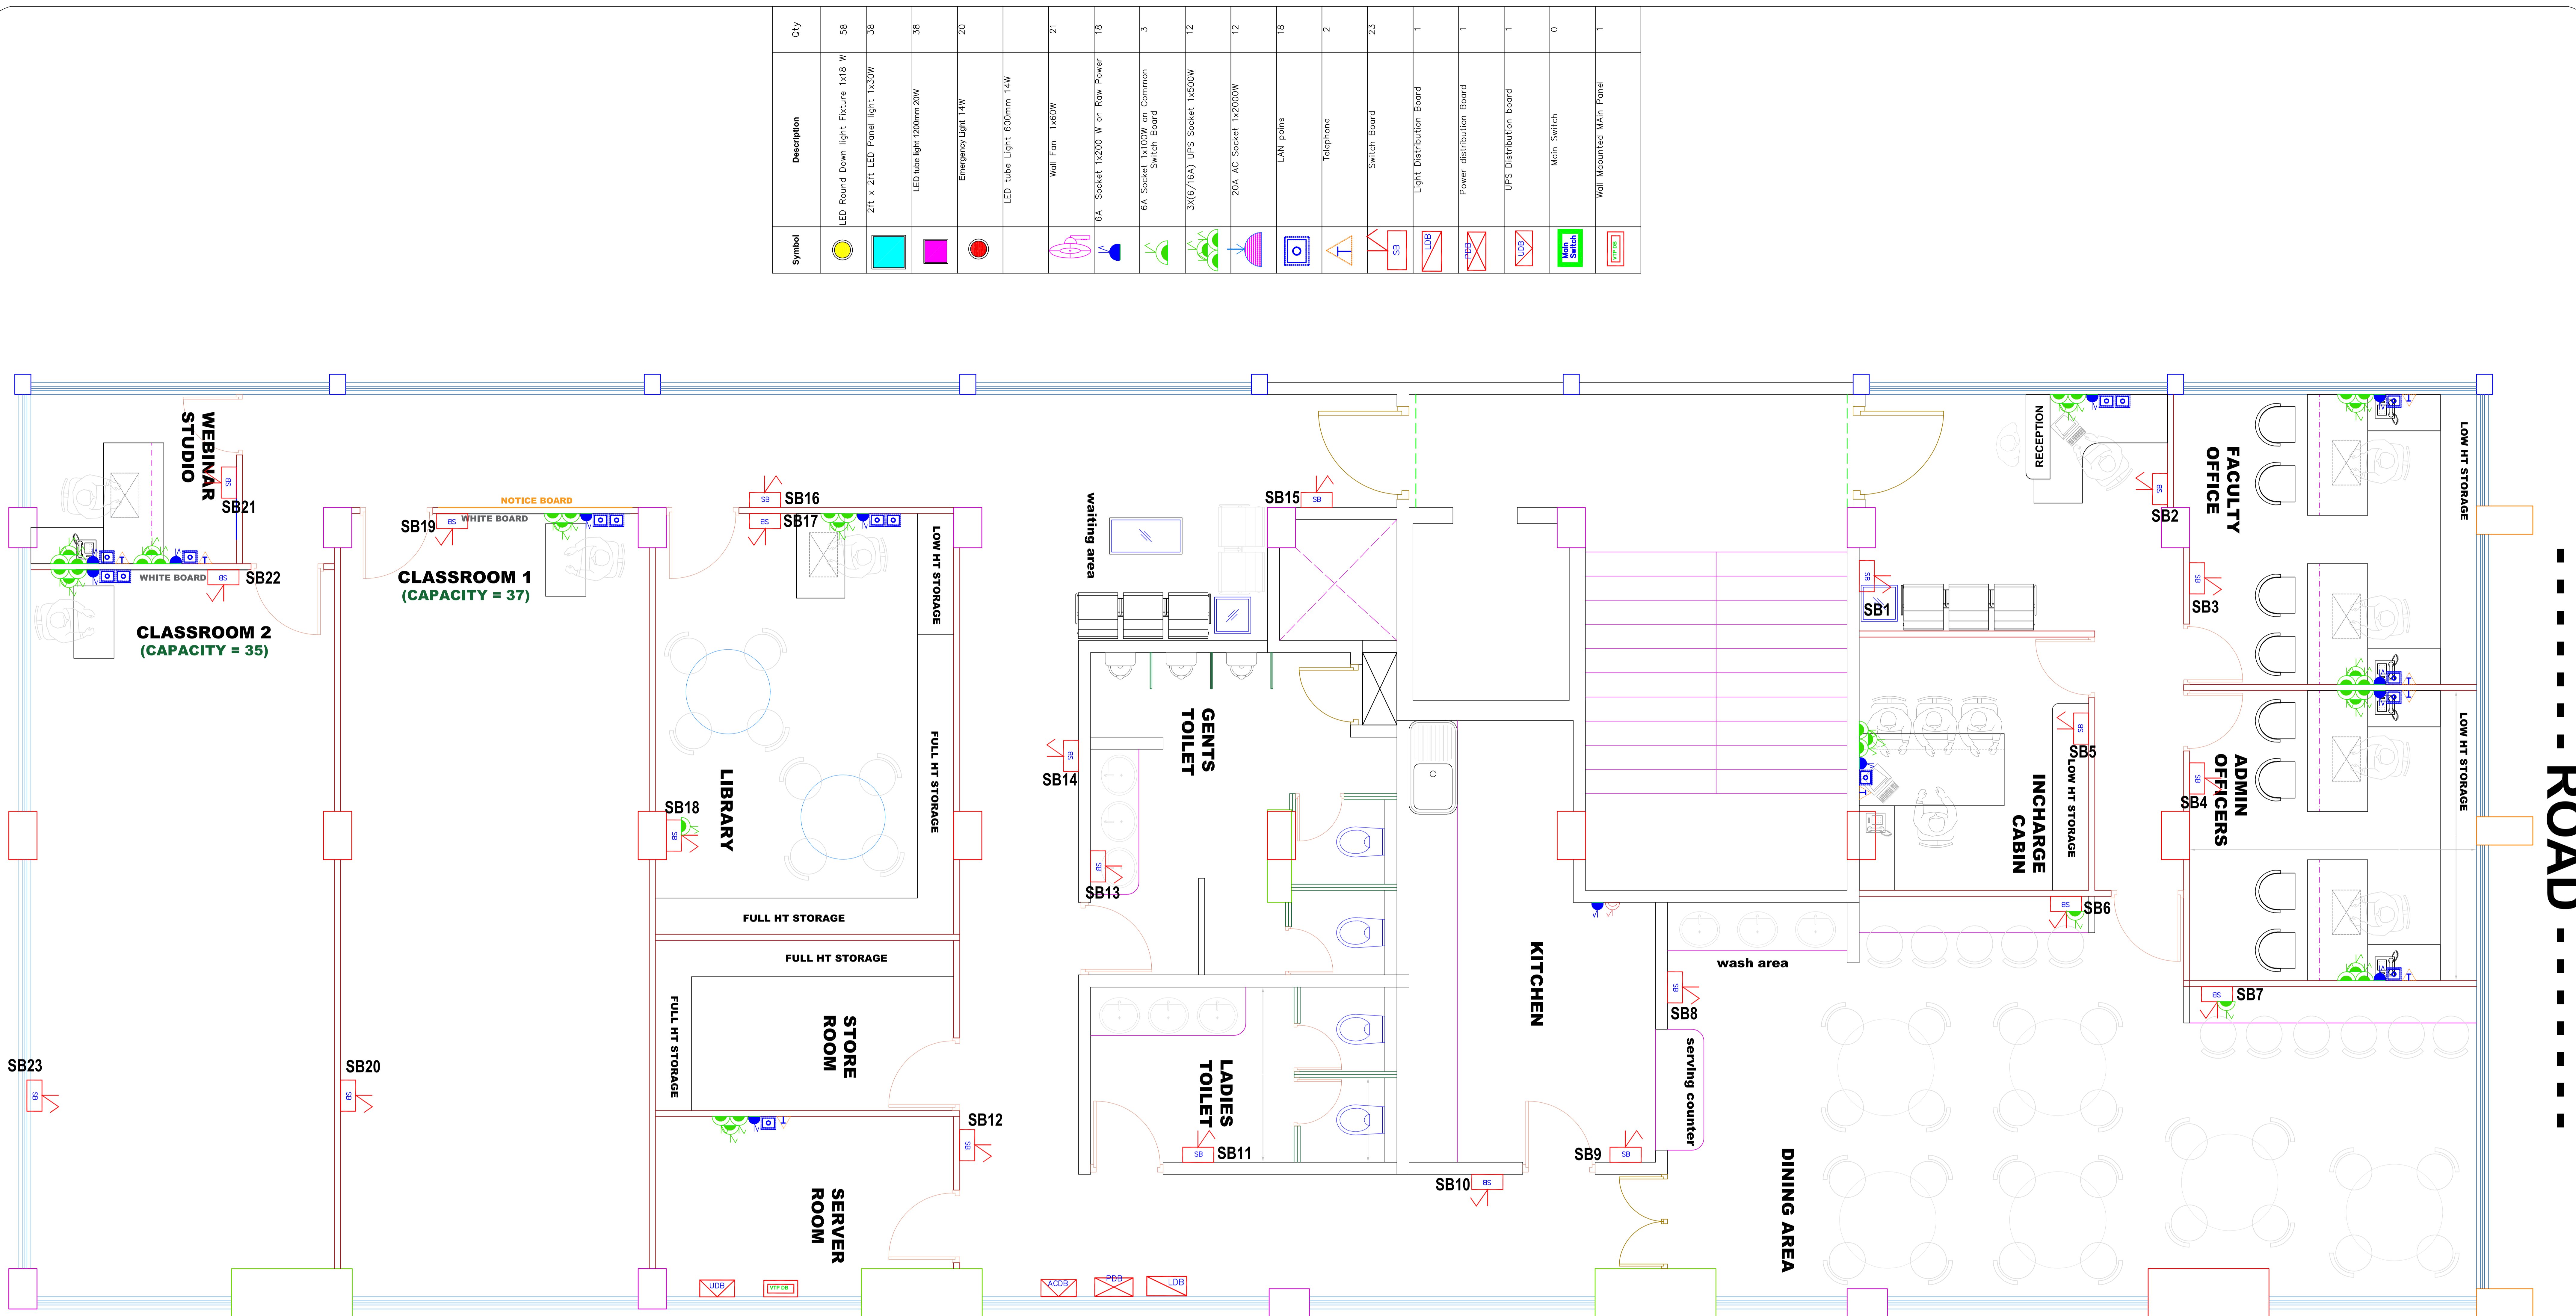


Symbol	Description	Qty
	LED Round Down light Fixture 1x18 W	58
	2ft x 2ft LED Panel light 1x30W	38
	LED tube light 1200mm 20W	38
	Emergency Light 1.4W	20
	LED tube Light 600mm 1.4W	
	Wall Fan 1x60W	21
	6A Socket 1x200 W on Row Power	18
	6A Socket 1x100W on Common Switch Board	3
	3x(6/16A) UPS Socket 1x350W	12
	20A AC Socket 1x2000W	12
	LAN points	18
	Telephone	2
	Switch Board	23
	Light Distribution Board	1
	Power distribution board	1
	UPS Distribution board	1
	Main Switch	0
	Wall Mounted Main Panel	1

UPS, RAW & LAN POINT WIRING OF IIBF CENTRE AT PANBAZAR, GUWAHATI

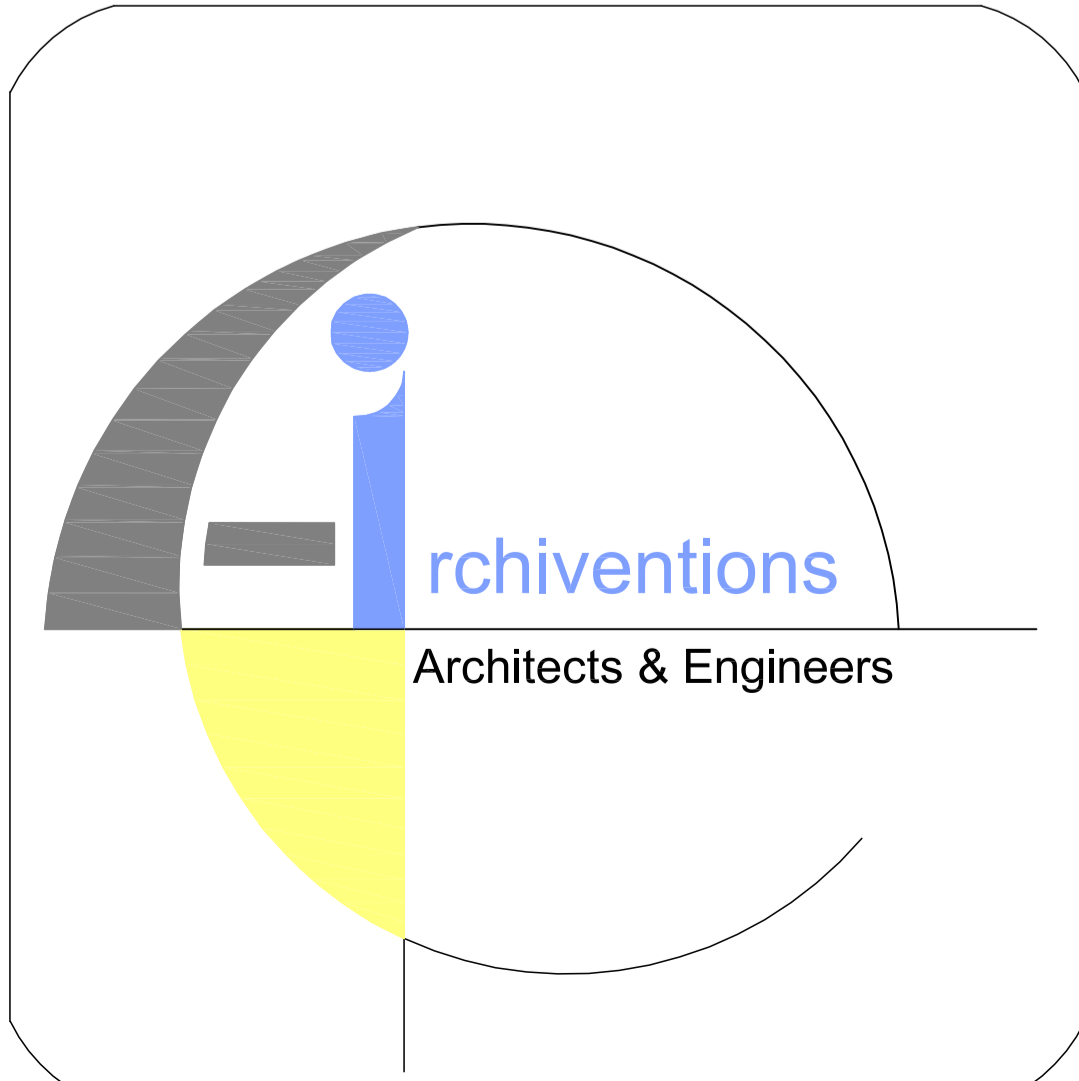CLIENT INDIAN INSTITUTE OF BANKING FINANCE Tower-1 , Commercial -II , Kohinoor City, Kuria West Mumbai – 400 070, Maharashtra, India.	Description of Proposal. APPROVED LAYOUT PLAN OF IIBF CENTRE AT PANBAZAR, GUWAHATI					SIGN & STAMP		FIRM NAME & ADDRESS ARCHIVENTIONS Architects , Planners & Interior Designers C.O.A. Regd. No.- CA / 2004 / 32922 ADDRESS HOUSE NO- 95, GROUND FLOOR LACHITNAGAR MAIN ROAD, LACHITNAGAR, GUWAHATI-781007, ASSAM PH-+91-9854062928/ 9436017122
	FLOOR PLAN	THIRD FLOOR PLAN						
	JOB NO.	DATE	SCALE	DEALT BY	DRG NO.			
				AR. DEBOJYOTI DEBROY	CHKD BY			

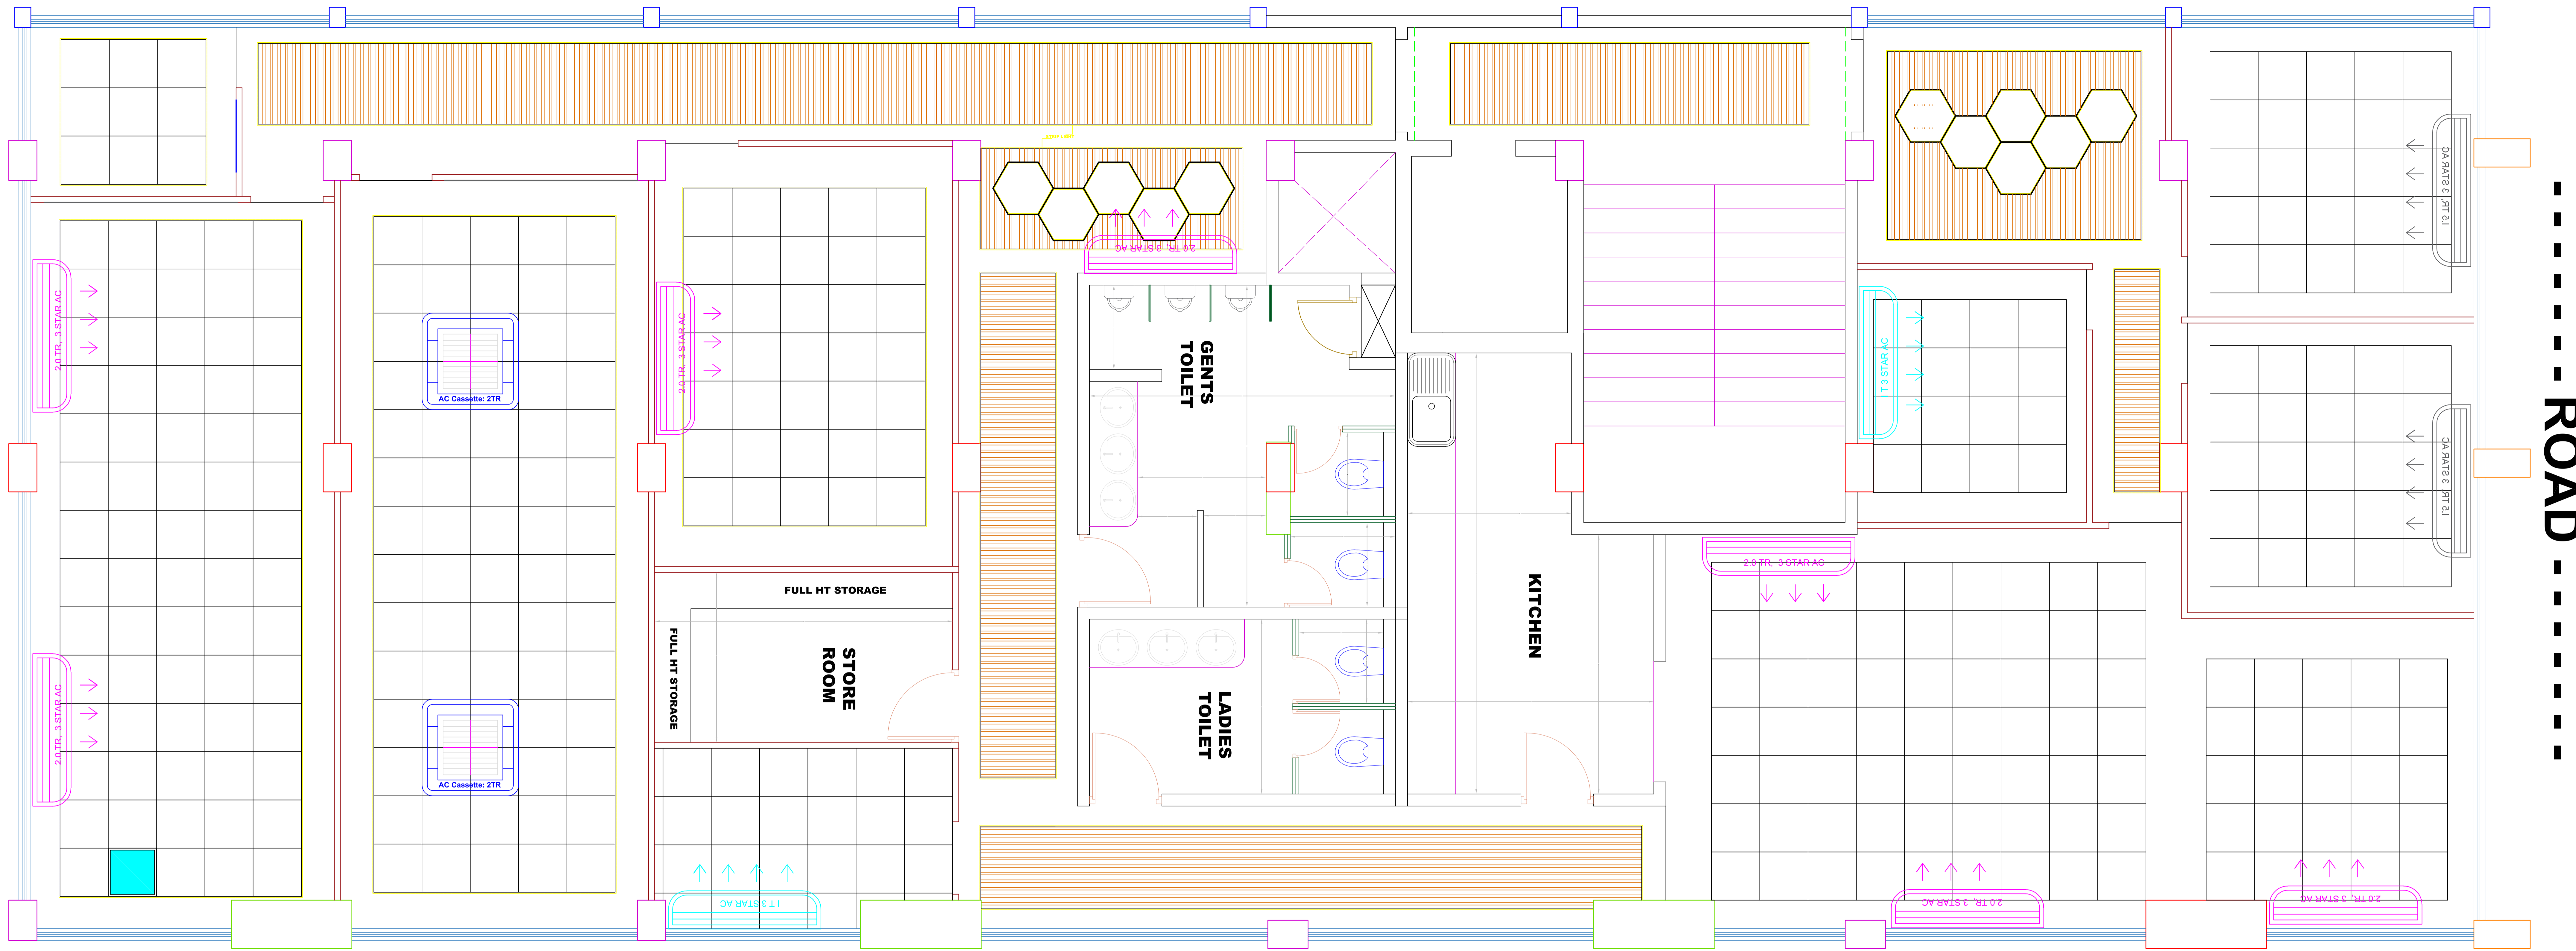

A.C. LAYOUT PLAN OF IIBF CENTRE AT GUWAHATI

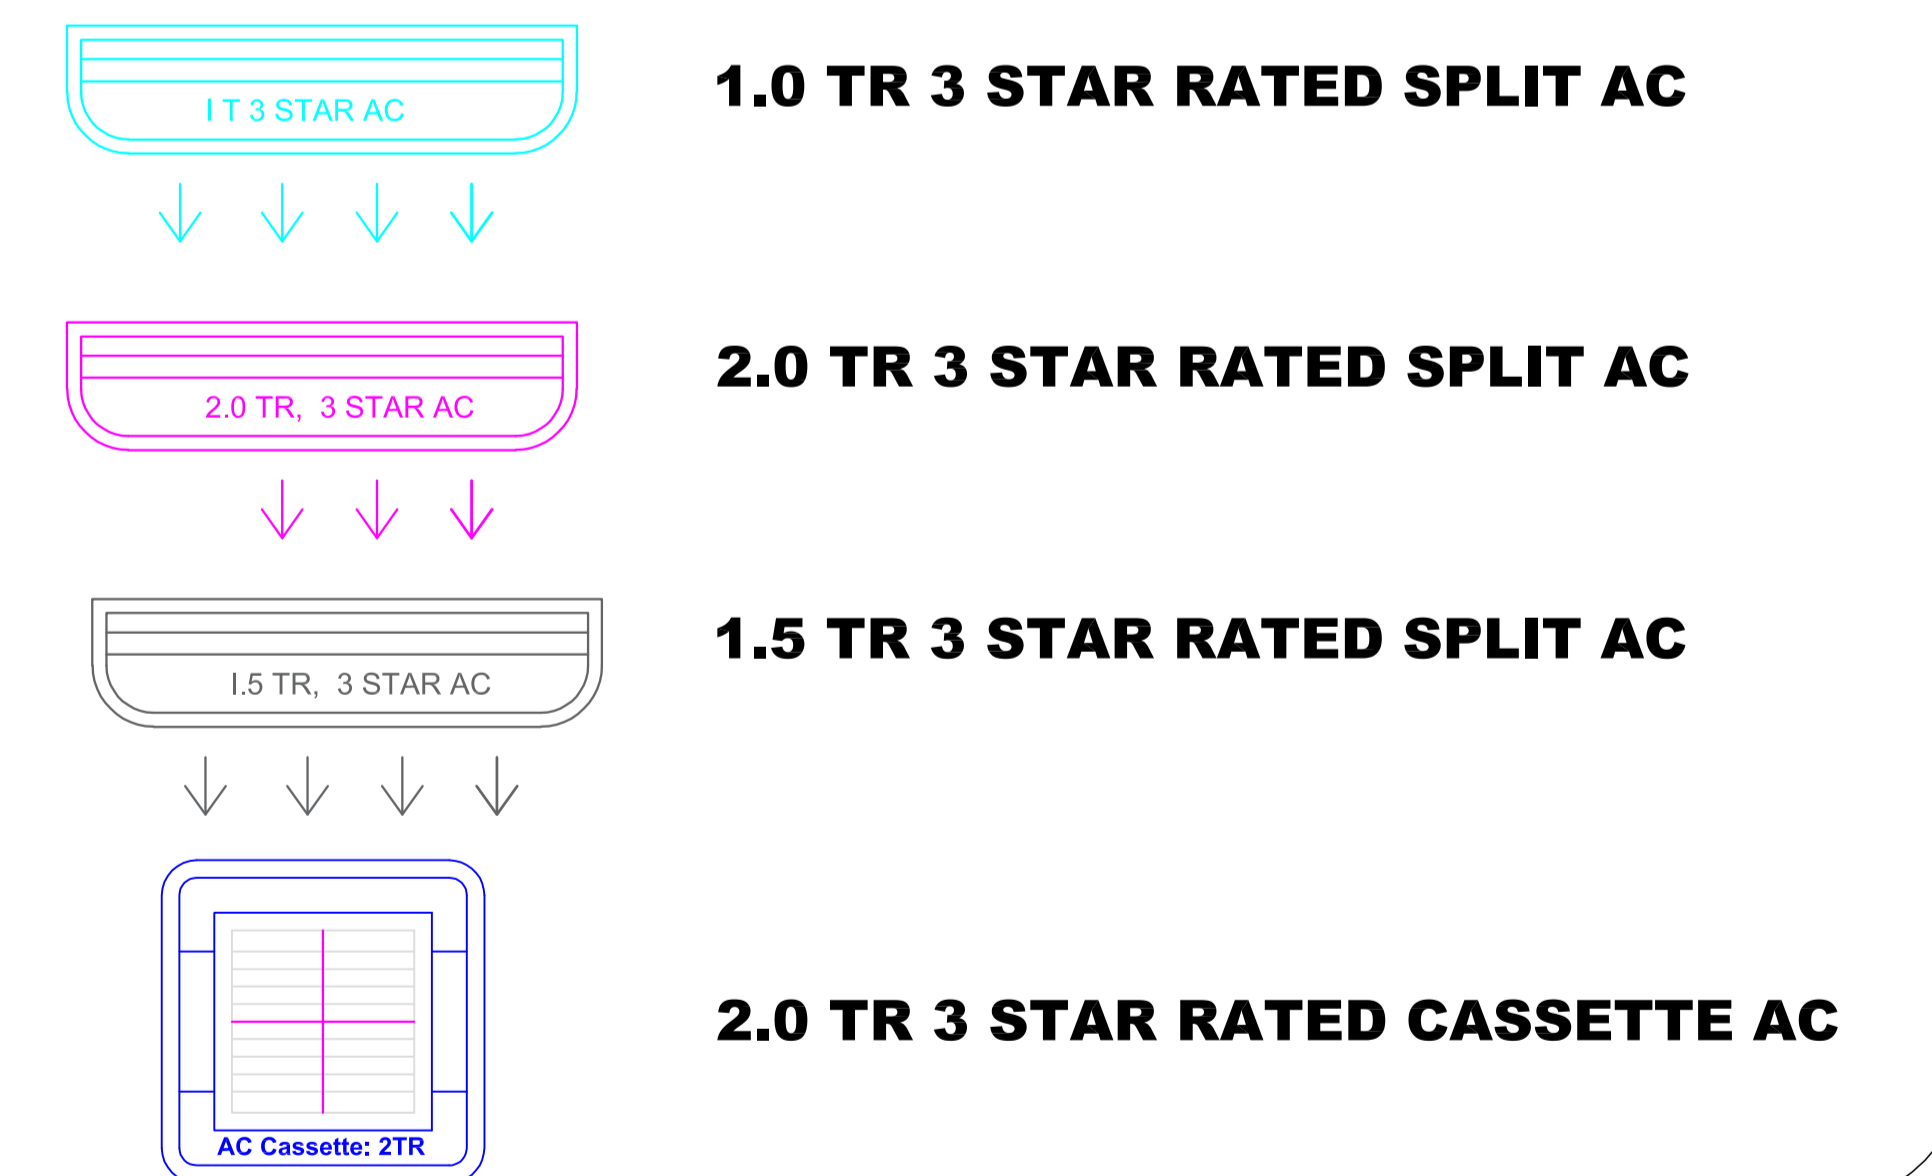

CLIENT
INDIAN INSTITUTE OF BANKING FINANCE
 Tower-1, Commercial -II, Kohinoor City, Kurla West
 Mumbai - 400 070, Maharashtra, India.




Description of Proposal.
PROPOSED LAYOUT PLAN OF IIBF TRAINING CENTRE

THIRD FLOOR PLAN

FLOOR PLAN

JOB NO.	DATE	SCALE	DEALT BY	CHKD BY	DRG NO.
			AR. DEBOJYOTI DEBROY		

SIGN & STAMP

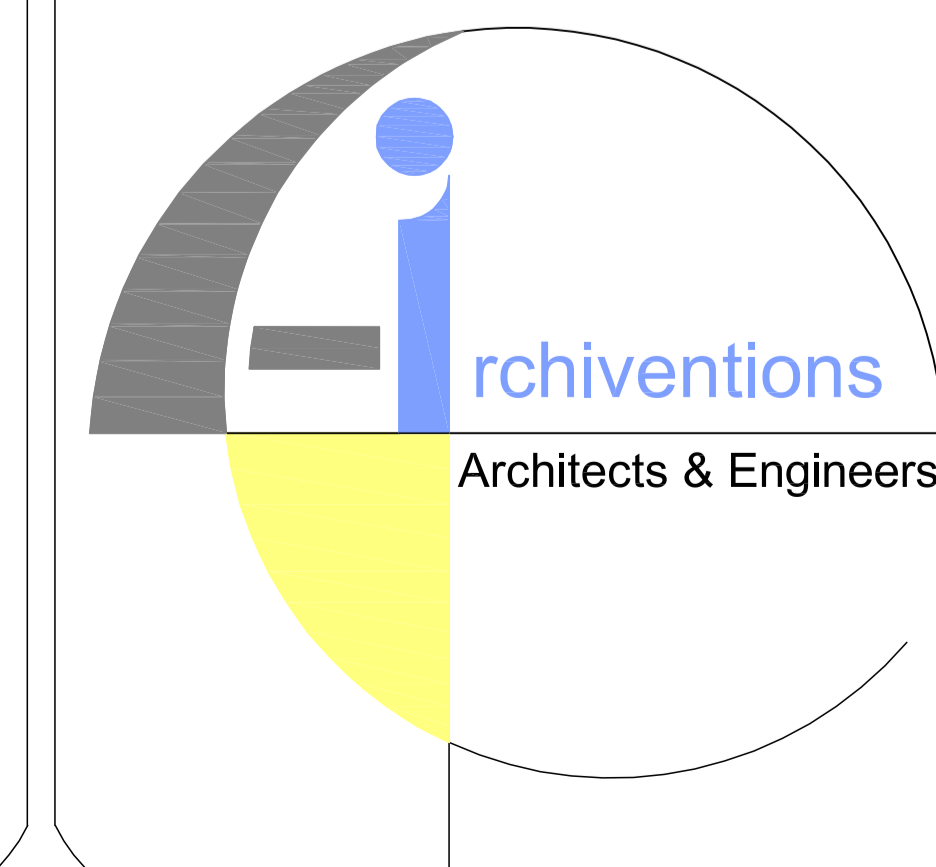


FIRM NAME & ADDRESS

ARCHIVENTIONS

Architects, Planners & Interior Designers
 C.O.A. Regd. No.- CA / 2004 / 32922


ADDRESS

HOUSE NO- 95, GROUND FLOOR
 LACHITNAGAR MAIN ROAD,
 LACHITNAGAR, GUWAHATI-781007, ASSAM
 PH-+91-9854062928/ 9436017122

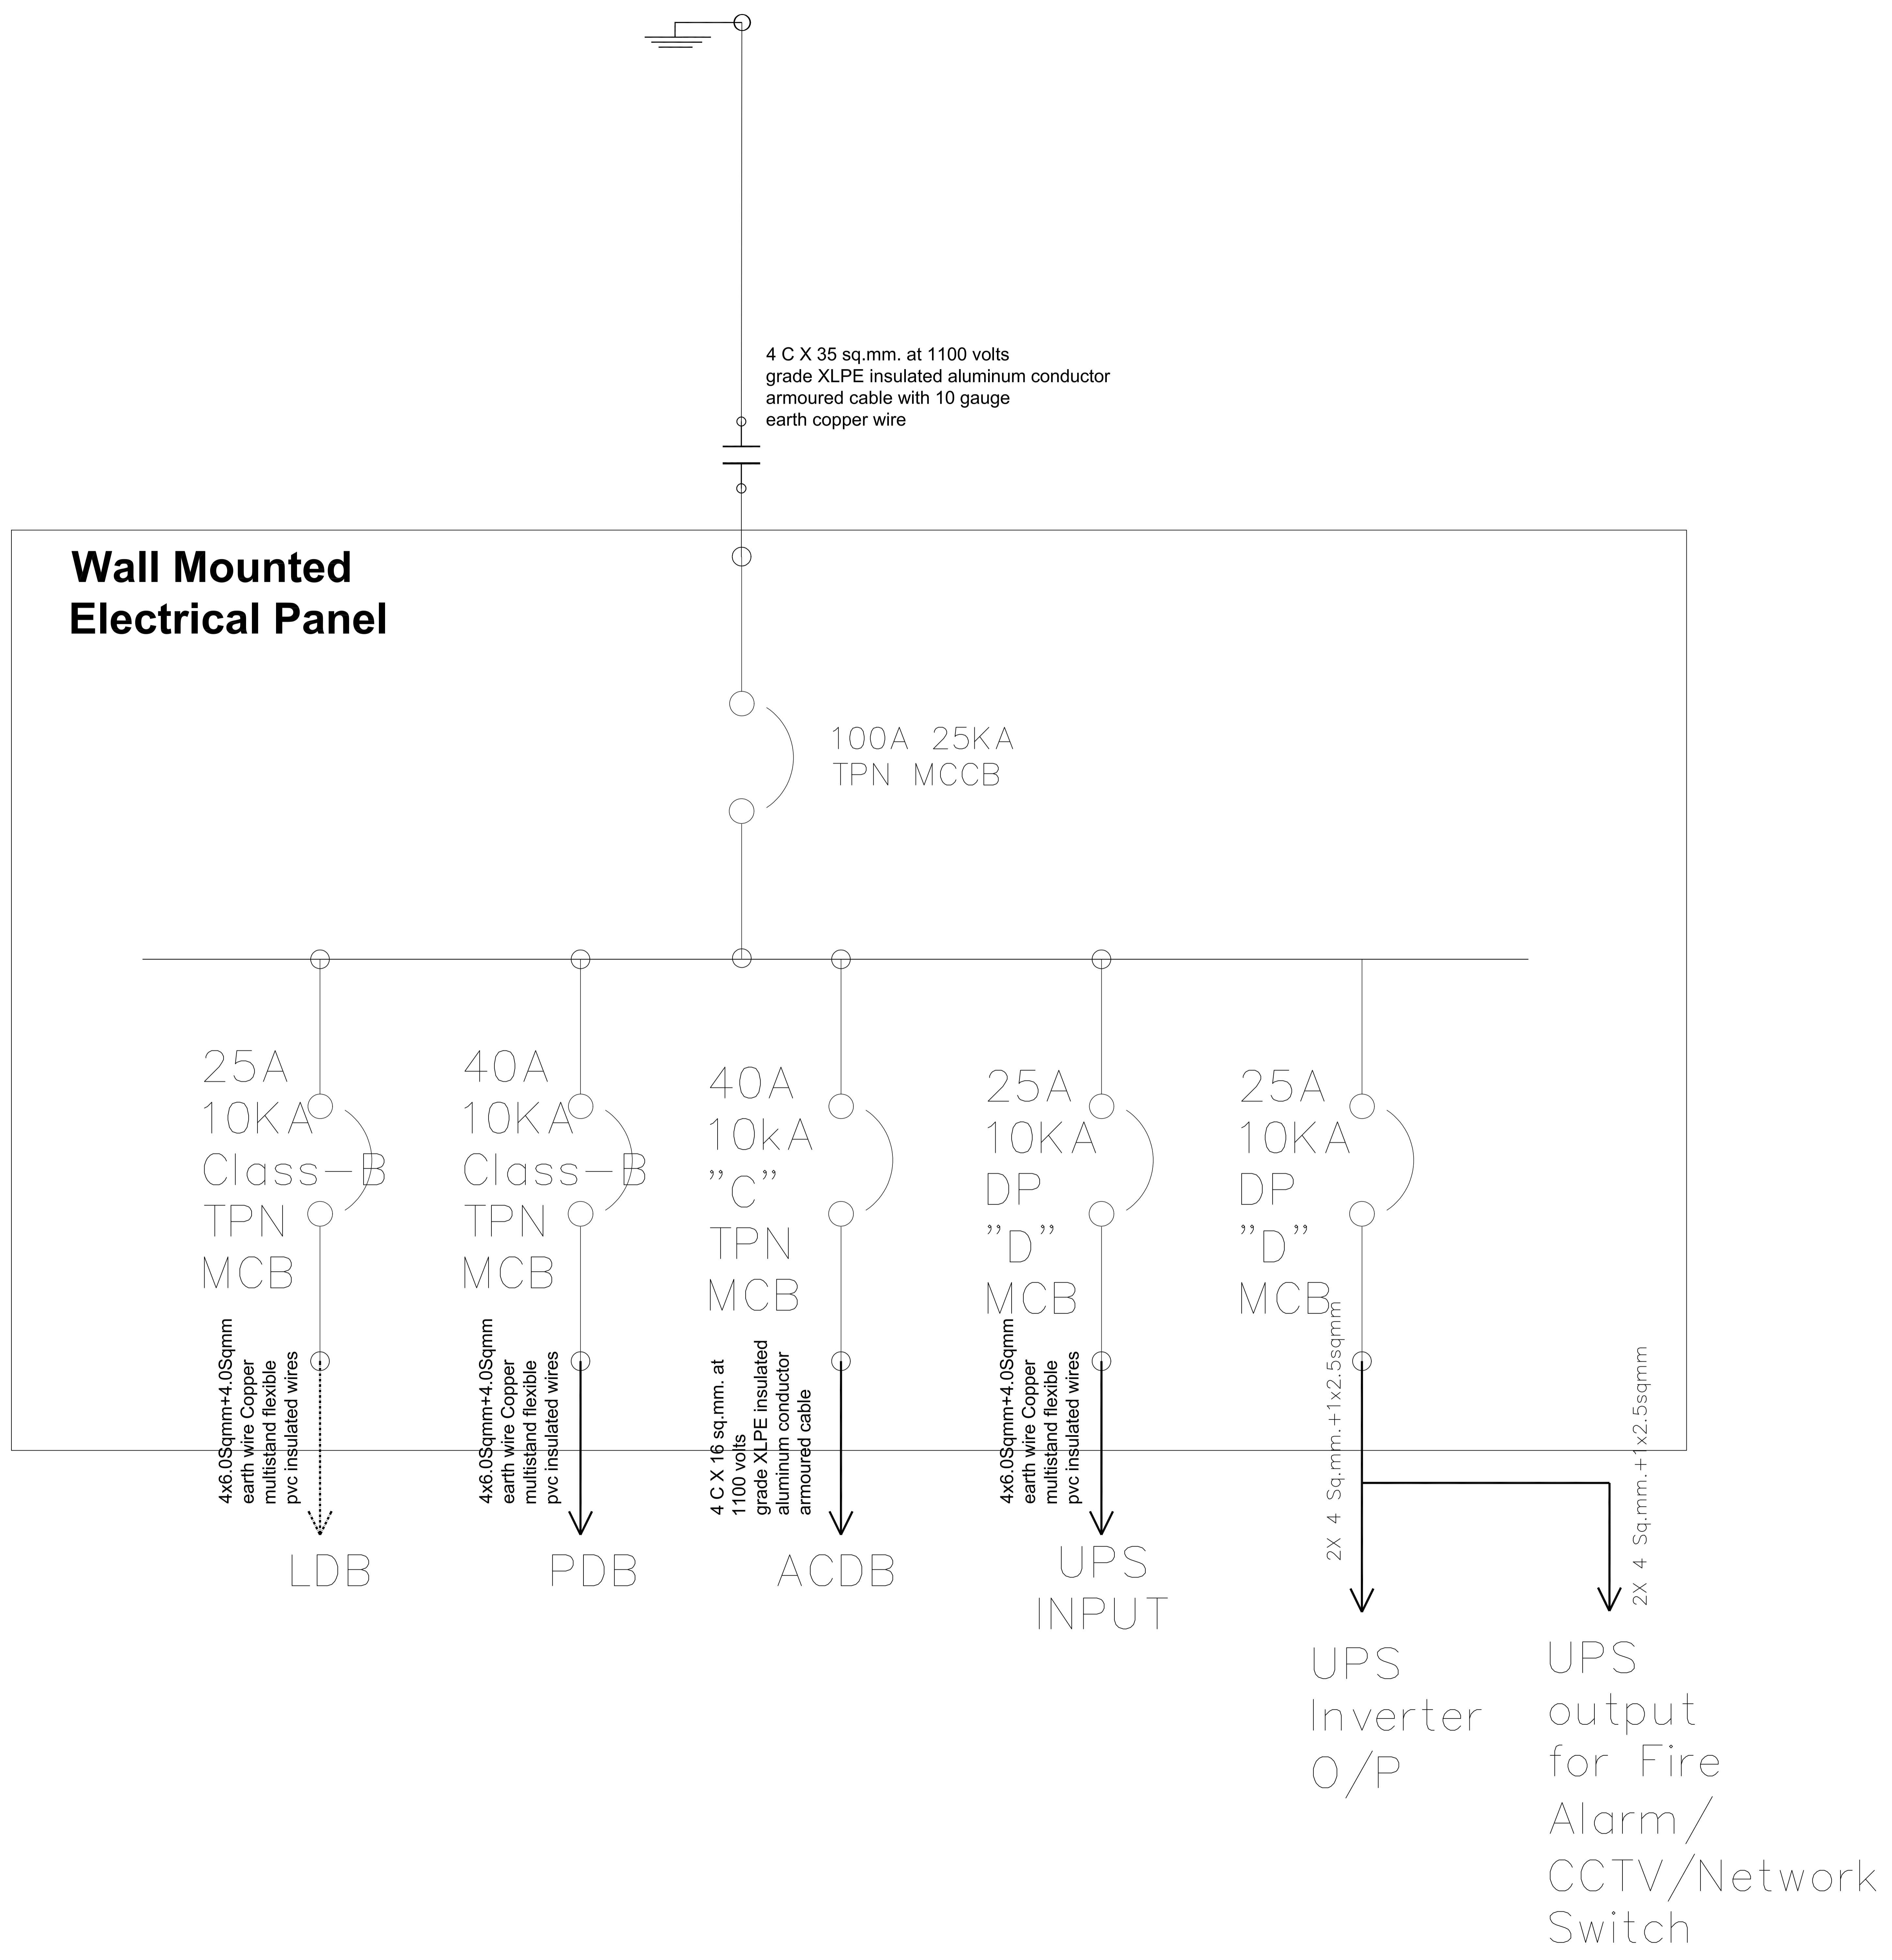

6 Way SP UPSDB-2

From UPS Inverter O/P
Plus
UPS output for Fire ALram/
CCTV/Network Switch

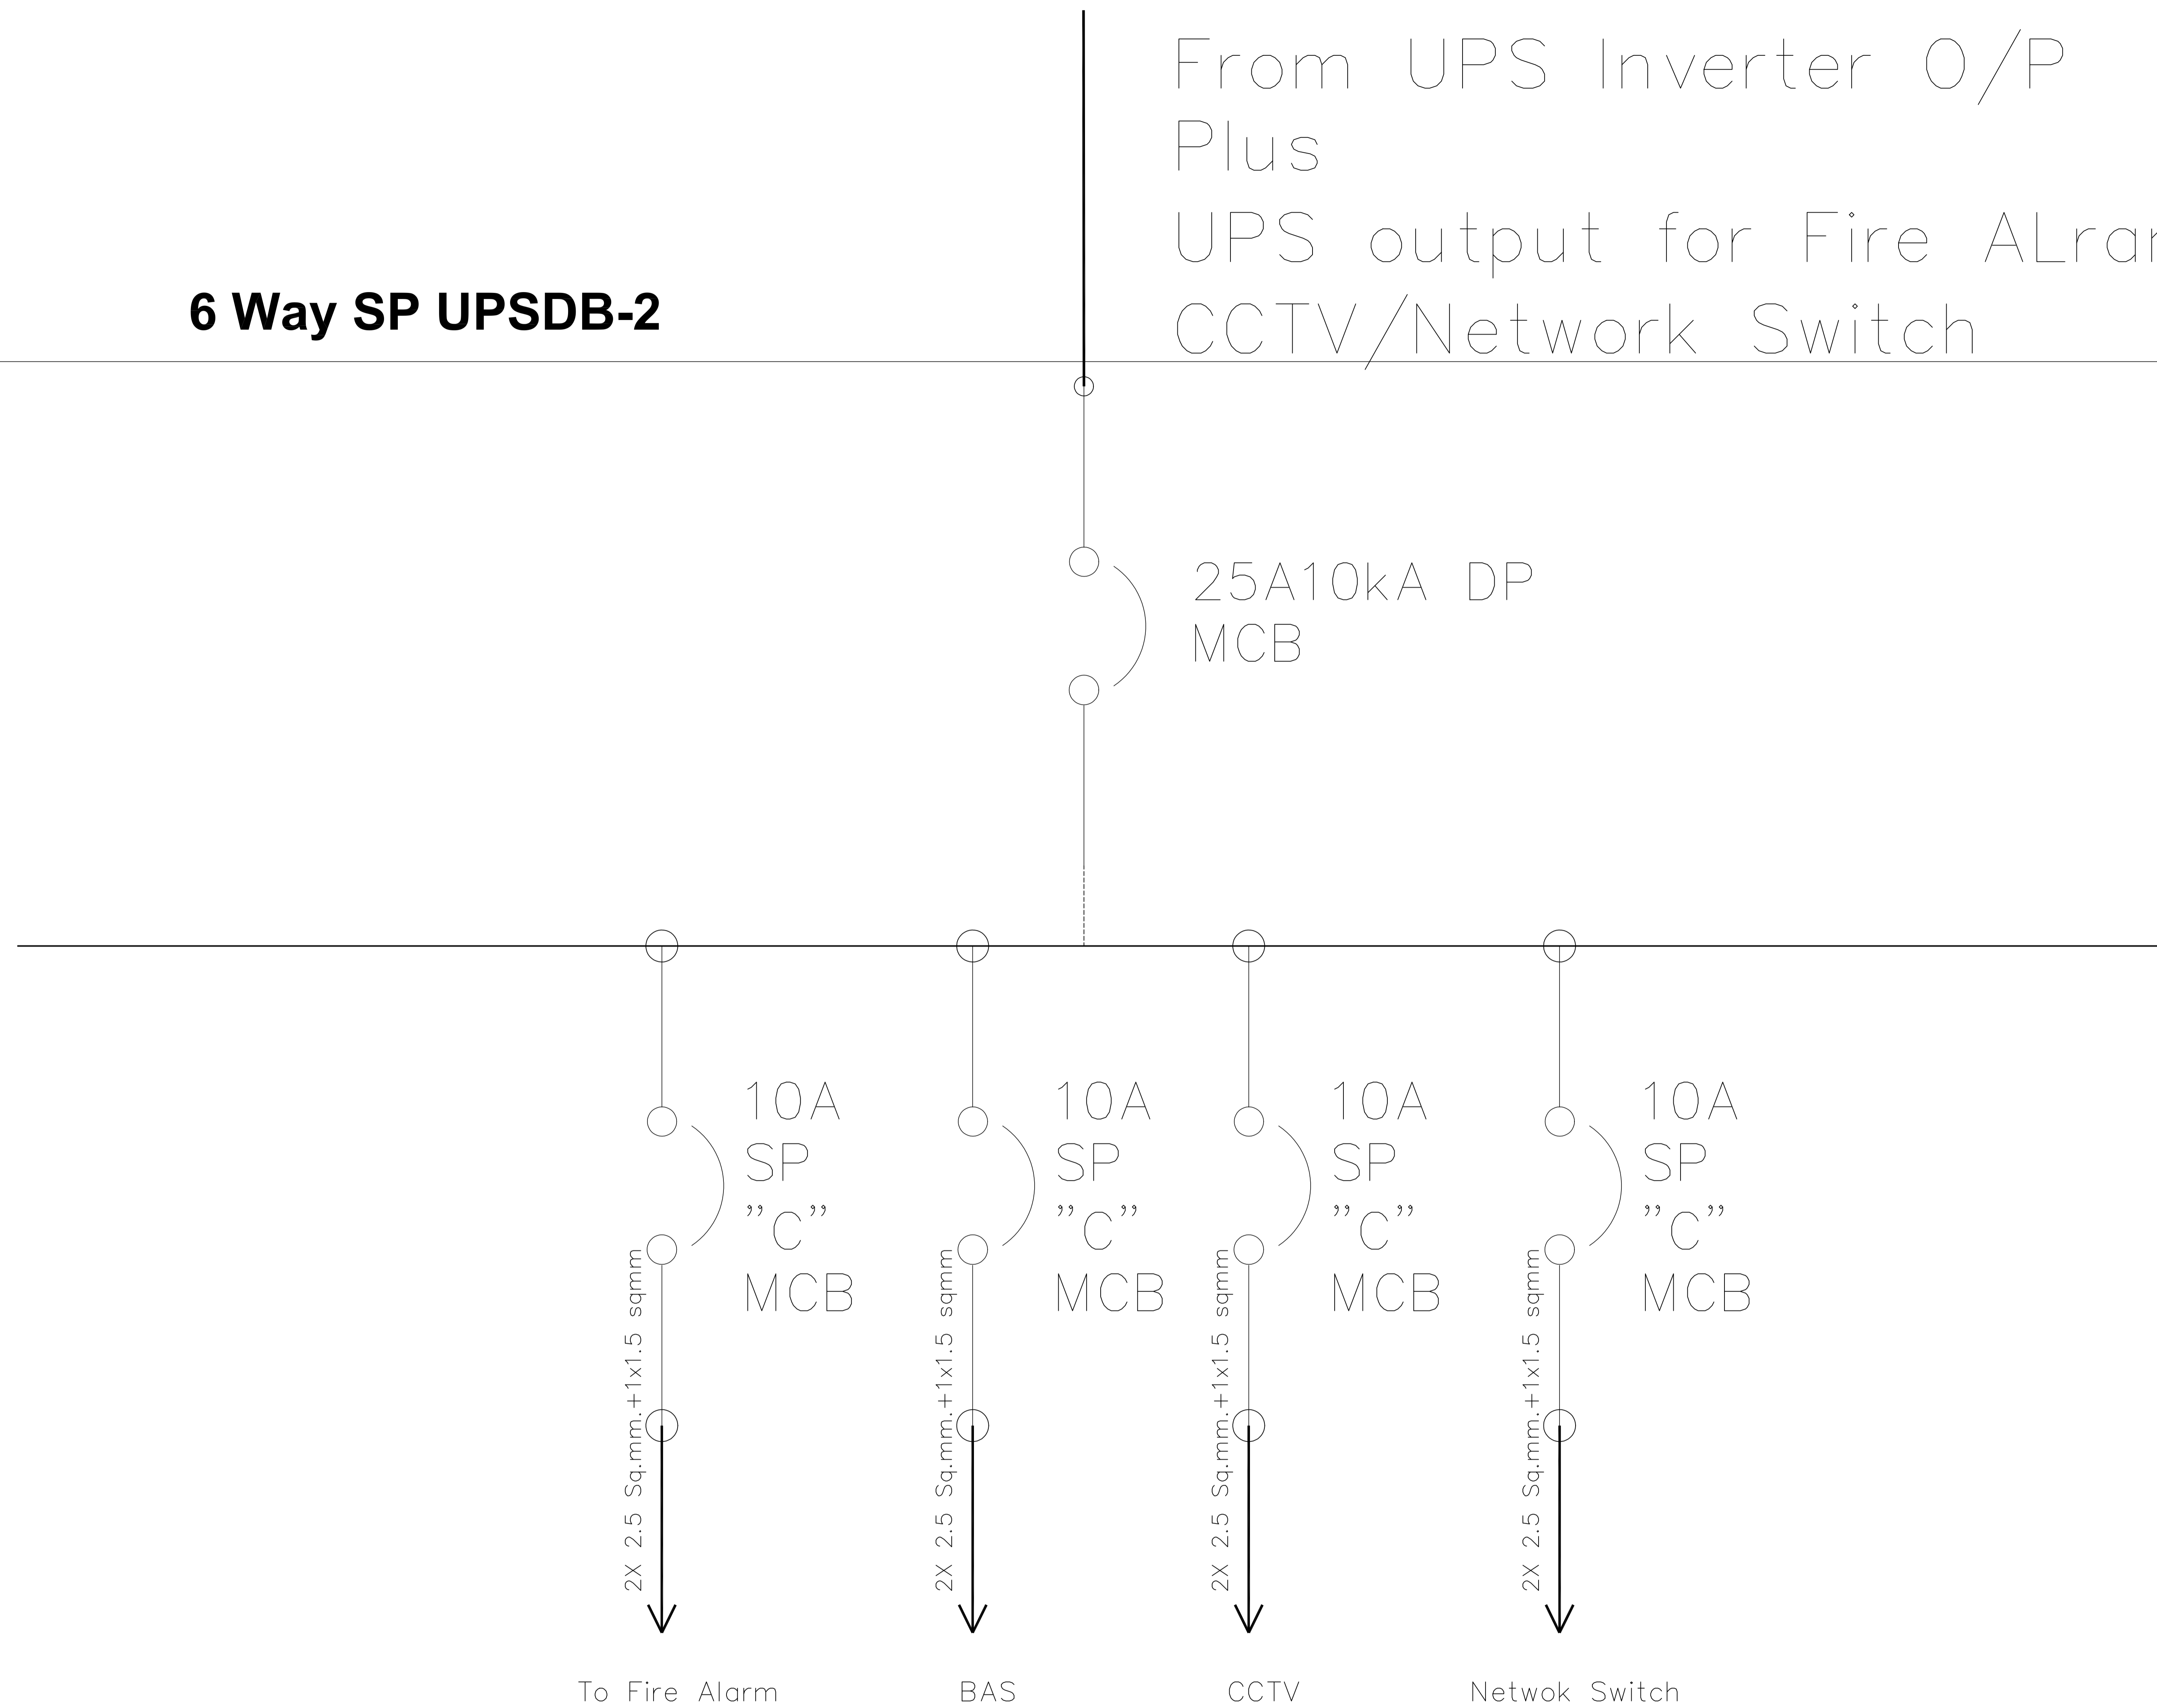

8 Way SPN UPSDB-1

4x6.0Sqmm +4.0Sqmm earth
wire Copper multistand flexible
pvc insulated wires

25A10kA DP
MCB

To Indicator
Bulb- Blue
5W

10A
SP
"D"
MCB

10A
SP
"D"
MCB

10A
SP
"D"
MCB

10A
SP
"D"
MCB

10A
SP
"D"
MCB

10A
SP
"D"
MCB

2X 2.5 Sq.mm.+1x1.5 sqmm

2X 2.5 Sq.mm.+1x1.5 sqmm


2X 2.5 Sq.mm.+1x1.5 sqmm

2X 2.5 Sq.mm.+1x1.5 sqmm

2X 2.5 Sq.mm.+1x1.5 sqmm

2X 2.5 Sq.mm.+1x1.5 sqmm

3X6A Socket-3 Sets 3X6A Socket-3 Sets 3X6A Socket-3 Sets 3X6A Socket-3 Sets Emergency Lights-10 Emergency Lights-10

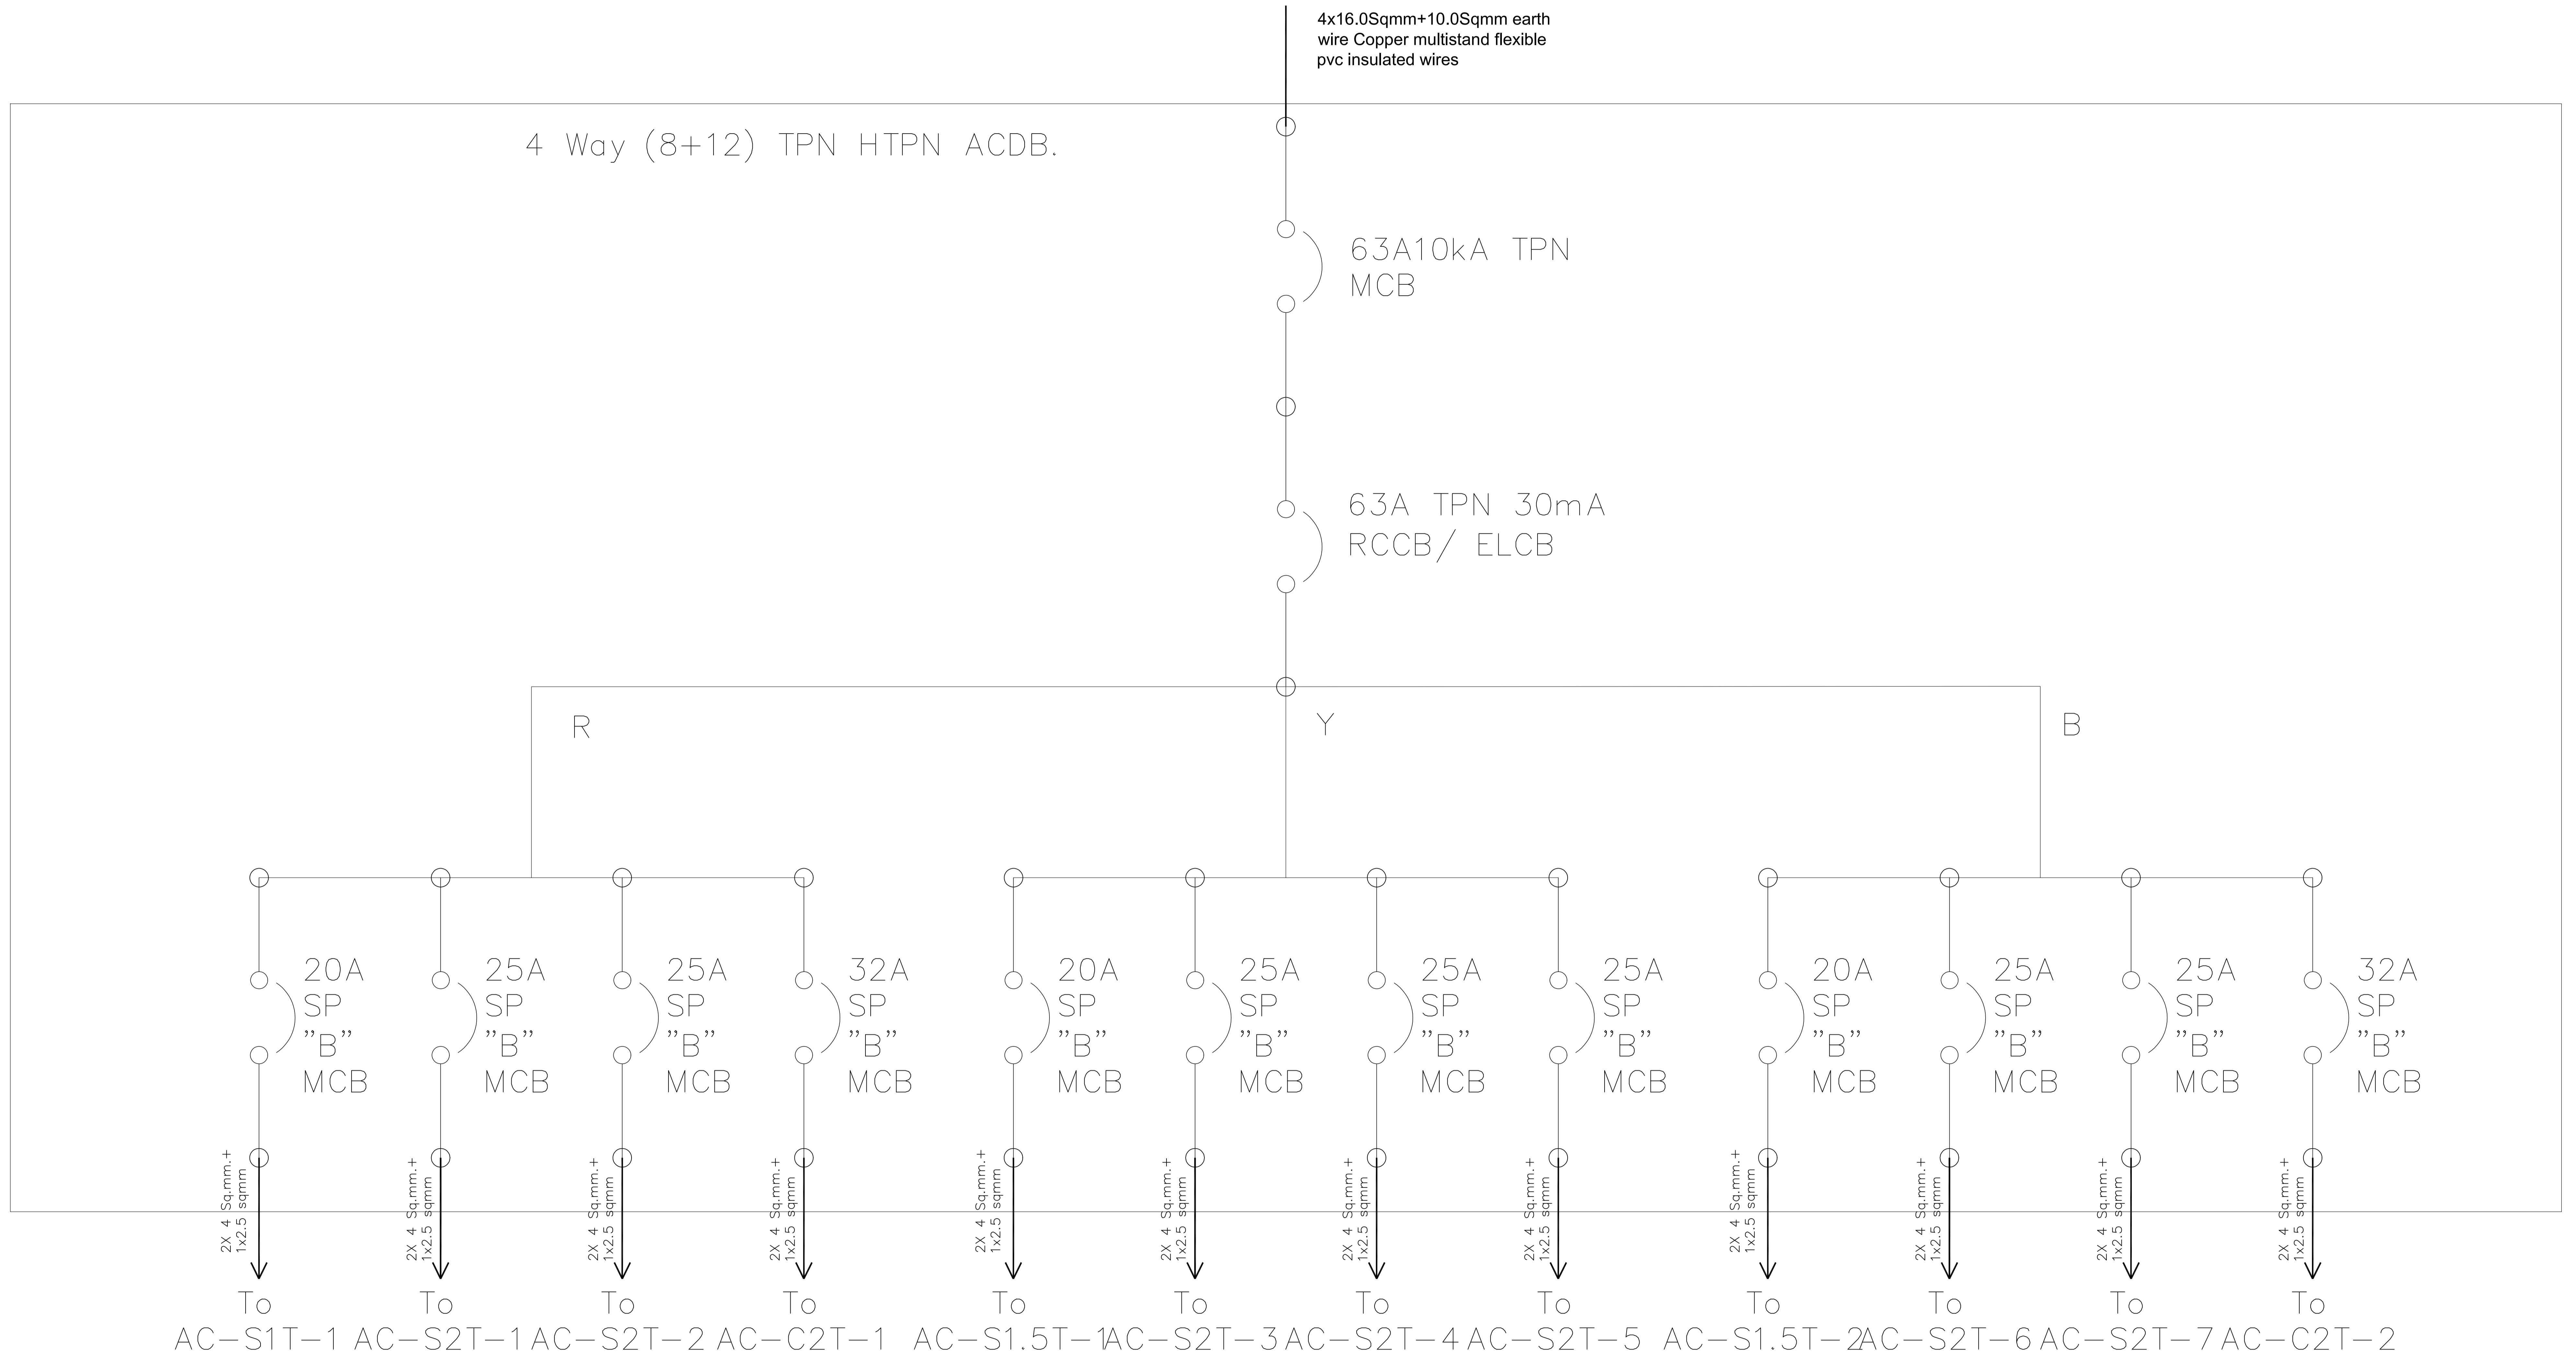

4x6.0Sqmm+4.0Sqmm earth wire
Copper multistand flexible
pvc insulated wires

4 Way (8+12) TPN HTPN PDB for
Raw Power.

40A10kA TPN
MCB

40A TPN 30mA
RCCB/ ELCB

R

Y

B

10A
SP
"B"
MCB

10A
SP
"B"
MCB

10A
SP
"B"
MCB

16A
SP
"B"
MCB

10A
SP
"B"
MCB

10A
SP
"B"
MCB

10A
SP
"B"
MCB

16A
SP
"B"
MCB

10A
SP
"B"
MCB

10A
SP
"B"
MCB

10A
SP
"B"
MCB

16A
SP
"B"
MCB

2X 2.5 Sq.mm.+
1x1.5 sqmm

2X 2.5 Sq.mm.+
1x1.5 sqmm

2X 2.5 Sq.mm.+
1x1.5 sqmm

2X 4 Sq.mm.+
1x2.5 sqmm

2X 2.5 Sq.mm.+
1x1.5 sqmm

2X 2.5 Sq.mm.+
1x1.5 sqmm

2X 2.5 Sq.mm.+
1x1.5 sqmm

2X 4 Sq.mm.+
1x2.5 sqmm

2X 2.5 Sq.mm.+
1x1.5 sqmm

2X 2.5 Sq.mm.+
1x1.5 sqmm

2X 2.5 Sq.mm.+
1x1.5 sqmm

2X 4 Sq.mm.+
1x2.5 sqmm

To
6A-2 Nos.

To
6A-2 Nos.

To
6A-2 Nos.

To
16A-1

To
6A-2 Nos.

To
6A-2 Nos.

To
6A-2 Nos.

To
6A-2 Nos.

To
16A-2

To
6A-2 Nos.

To
6A-2 Nos.

To
6A-2 Nos.

To
6A-2 Nos.

To
16A-3

